

KEY TO SYMBOLS

-  6X UP/DOWN LIGHT
-  2X SPIKE/ACCENT LIGHTS
-  8500mm LONG STRIP LIGHTING

 

LIGHTING PALETTE





ACCENT LIGHTS UP/DOWN LIGHT

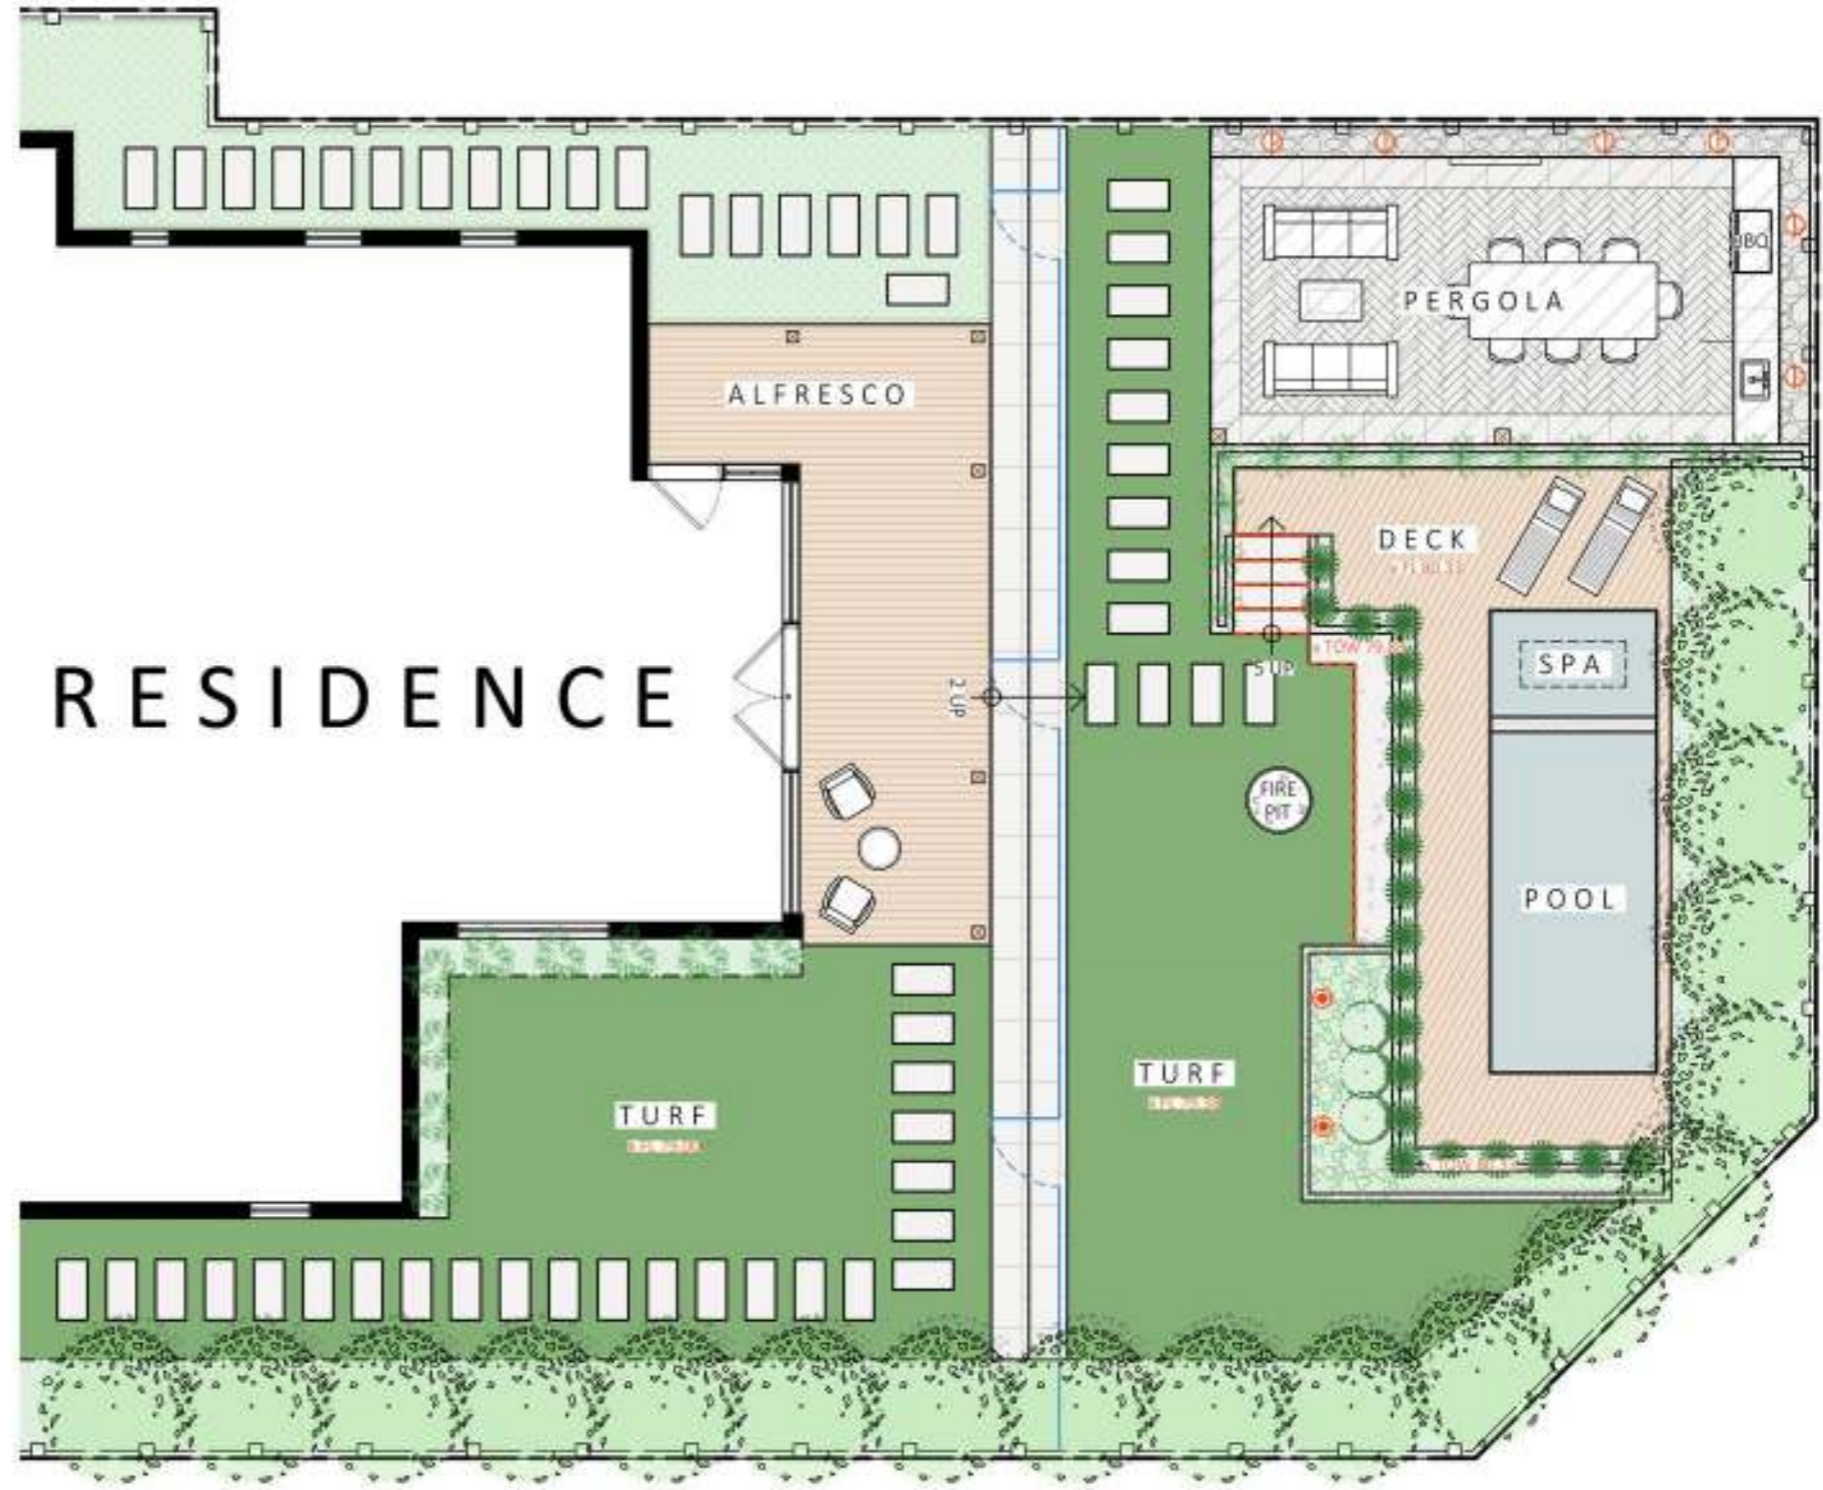

STEP LIGHTS



SCALE 1:100

<p>DWG TITLE: <b>LIGHTING PLAN</b></p>		<p>DWG NO. <b>3</b></p>	<p>REV. <b>A</b></p>	<p>SCALE: 1:100@A3 DATE: 31 January 2024</p>	
--	---	-----------------------------	--------------------------	--	---